



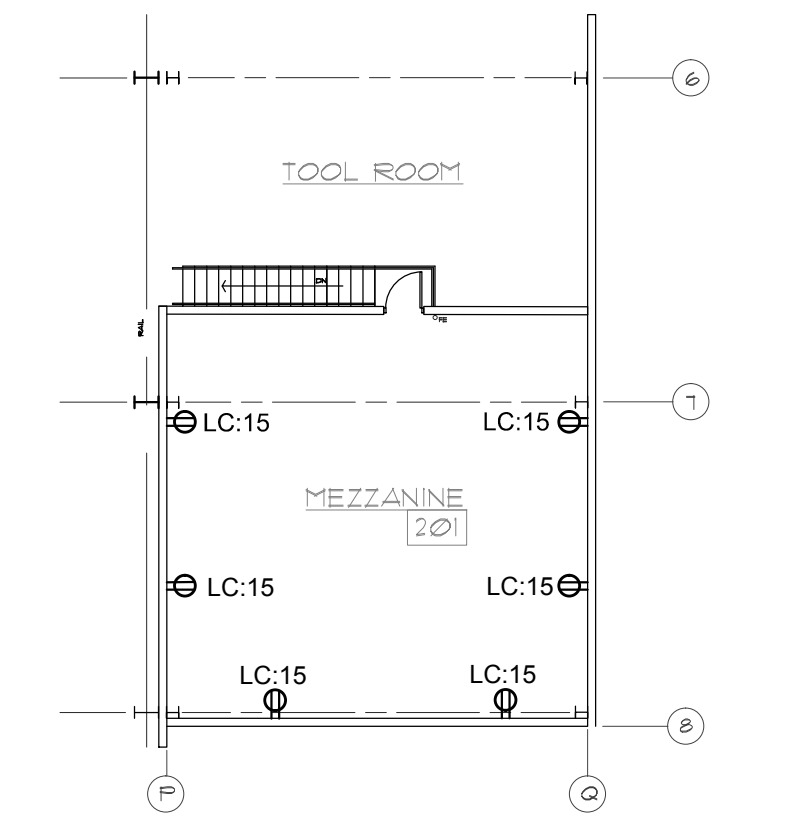

karpinski
ENGINEERING

3135 EUCLID AVENUE
CLEVELAND, OH 44115
P 216.391.3700
W karpinskieng.com

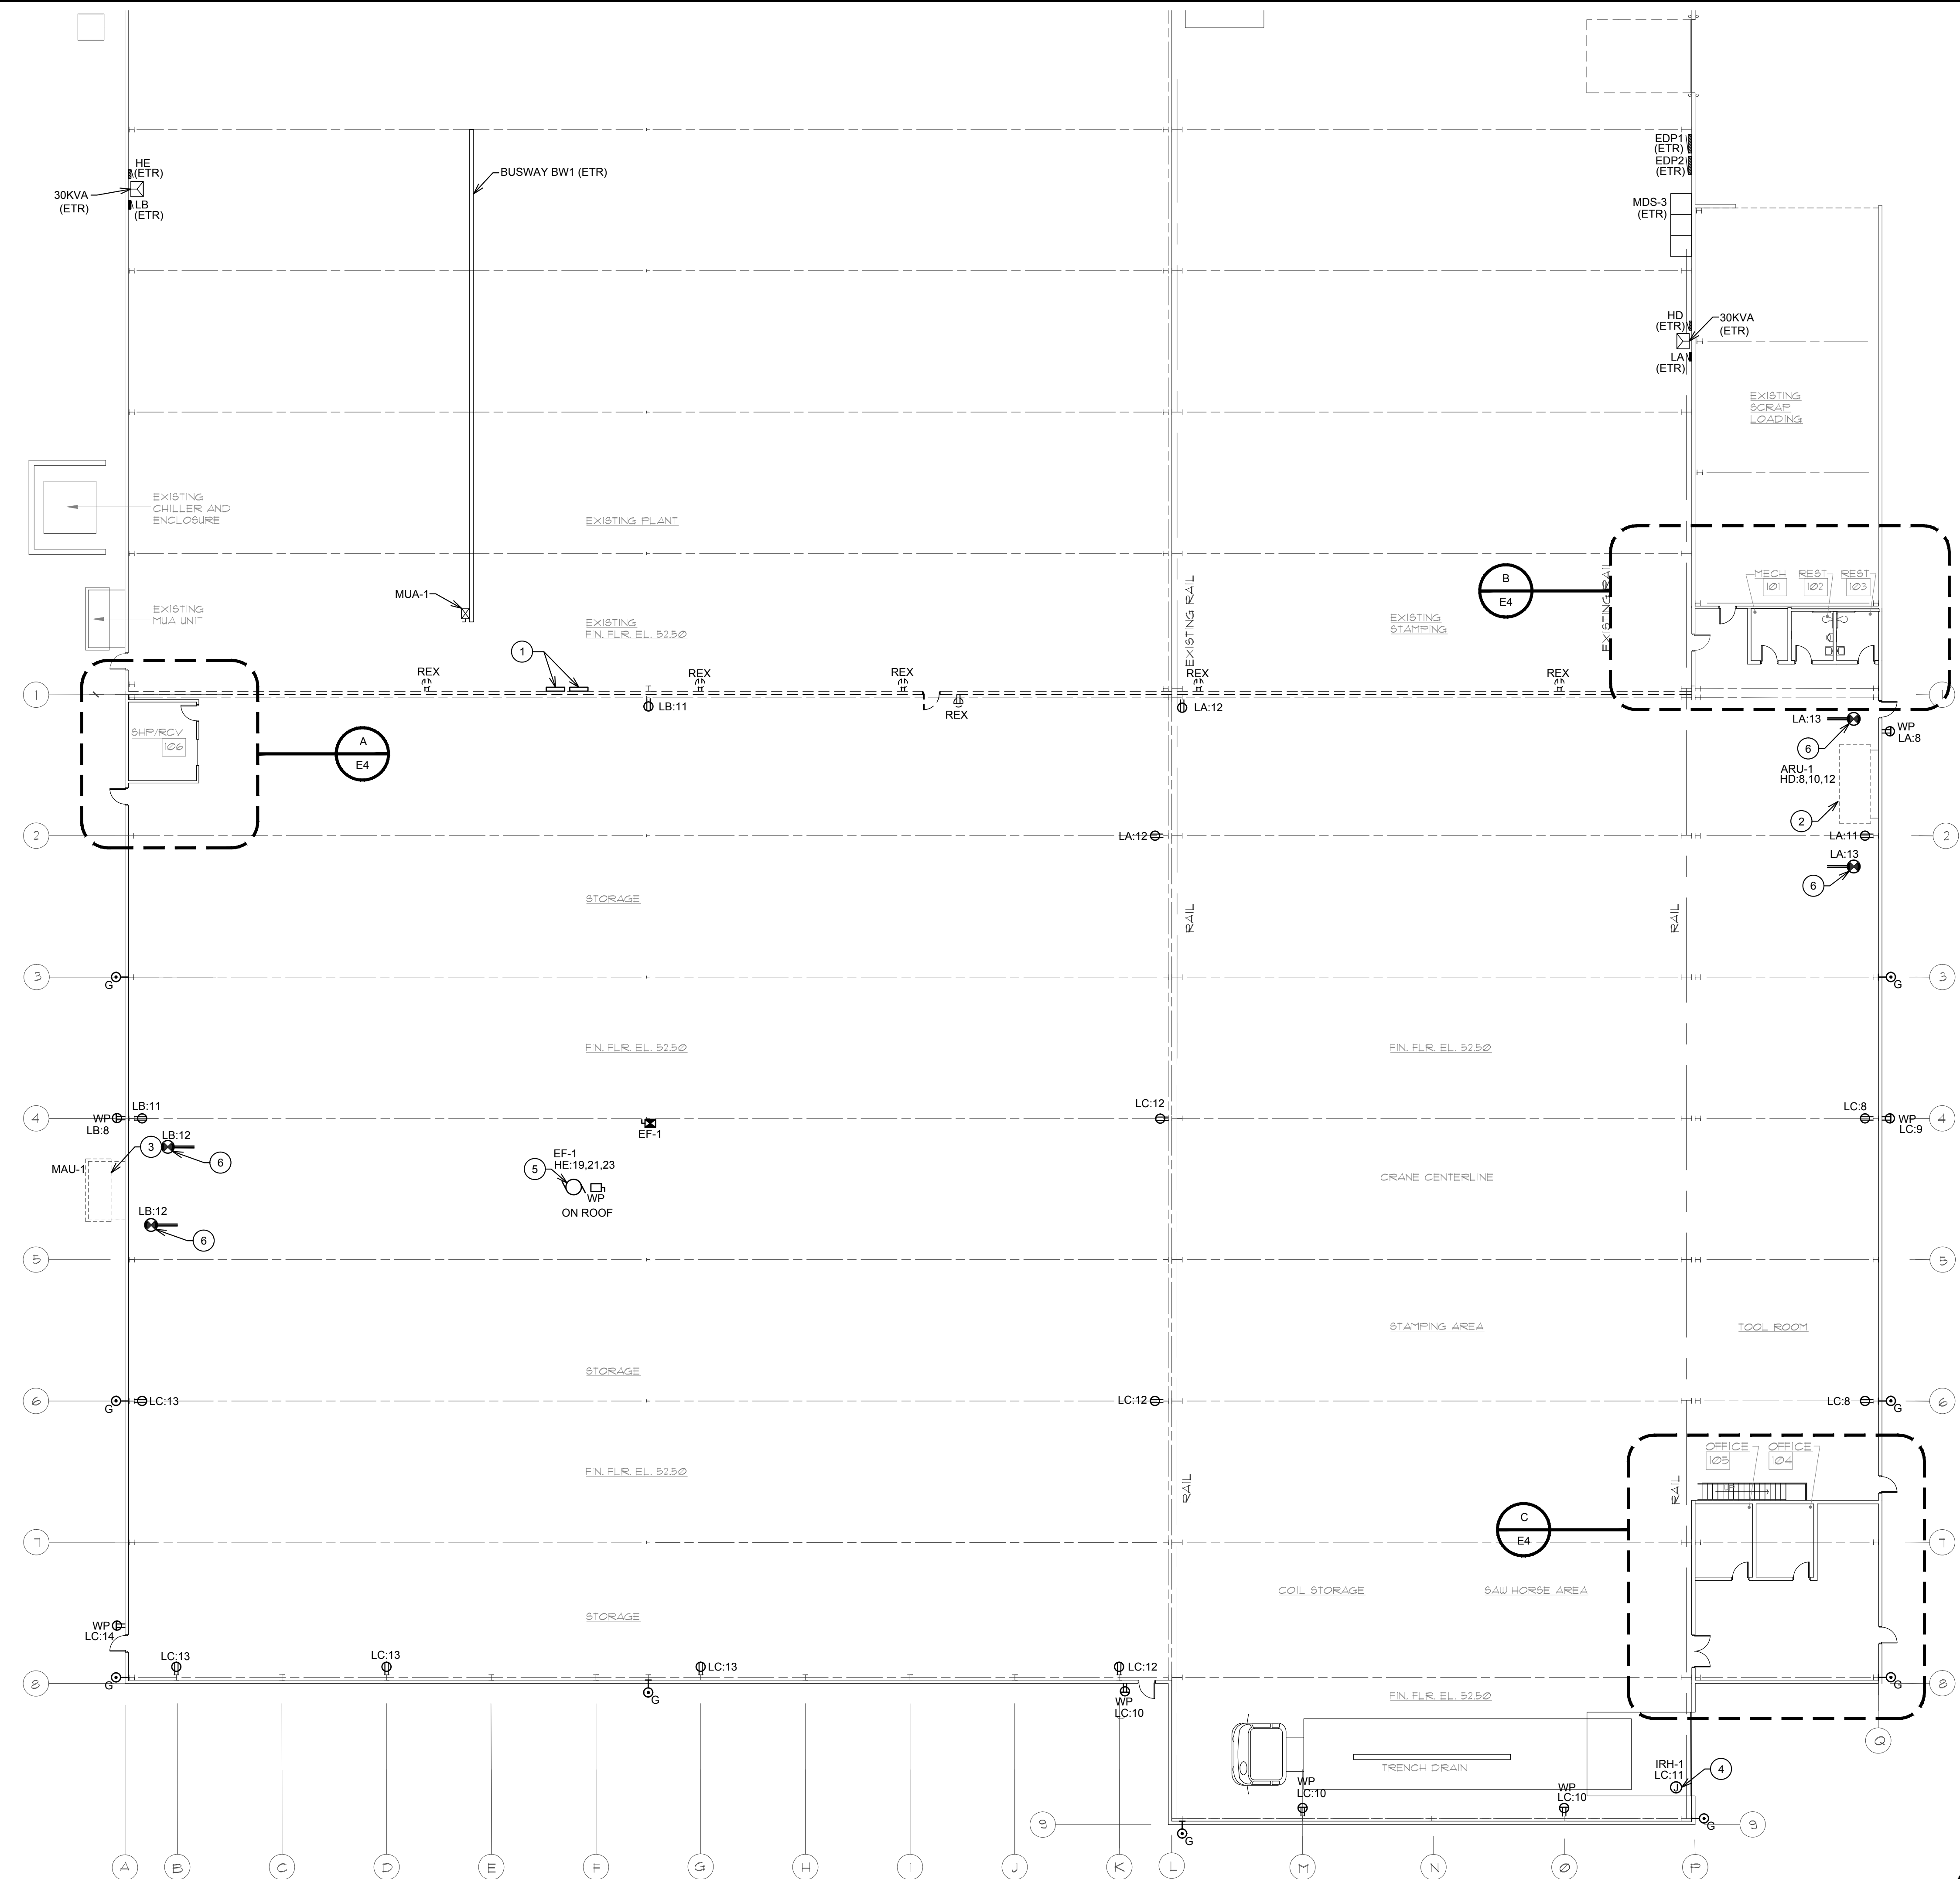


MEZZANINE ELECTRICAL PLAN
SCALE: 1/16" = 1'-0"

- PLAN NOTES**
- EXISTING PAINT LINE CONTROL PANELS. INSTALL STRUT SUPPORTS FROM FLOOR AS REQUIRED TO FACILITATE REMOVAL OF THE WALL AND ASSOCIATED BRACING.
 - AIR ROTATION UNIT ARU-1 (480V, 3Ø, (2) 7.5HP)) WITH INTEGRAL DISCONNECT SWITCH. PROVIDE 3#8, 1#10G, 1"C AND BRANCH CIRCUIT.
 - MAKEUP AIR UNIT MAU-1 (480V, 3Ø, 30HP) WITH INTEGRAL DISCONNECT SWITCH. REFER TO ONE LINE DIAGRAM FOR MORE INFORMATION.
 - HEATER IRH-1 (120V, 1Ø, 0.2KW) WITH INTEGRAL DISCONNECT SWITCH. PROVIDE 2#12, 1#12GND, 3/4"C BRANCH CIRCUIT.
 - EXHAUST FAN EF-1 (480V, 3Ø, 2HP) LOCATED ON ROOF. PROVIDE 3#12, 1#12GND, 3/4"C BRANCH CIRCUIT. LOCAL 30A, NEMA 3R DISCONNECT, AND FVNR #0 COMBINATION STARTER WITH 30AS 6AF.
 - SUPPLY OR RETURN DUCT DETECTORS. PROVIDE 120V BRANCH CIRCUIT INDICATED AND 120V INTERLOCK TO UNIT CONTROL DUCT DETECTOR SHALL BE PHOTOELECTRIC TYPE WITH SAMPLING TUBE; SYSTEM SENSOR #DH10ACDCLP.

ELECTRICAL PLAN
SCALE: 1/16" = 1'-0"

DEMOLITION NOTE
ALL ELECTRICAL DEVICES AND EQUIPMENT SHOWN DASHED SHALL BE REMOVED (REX), UNLESS OTHERWISE NOTED.

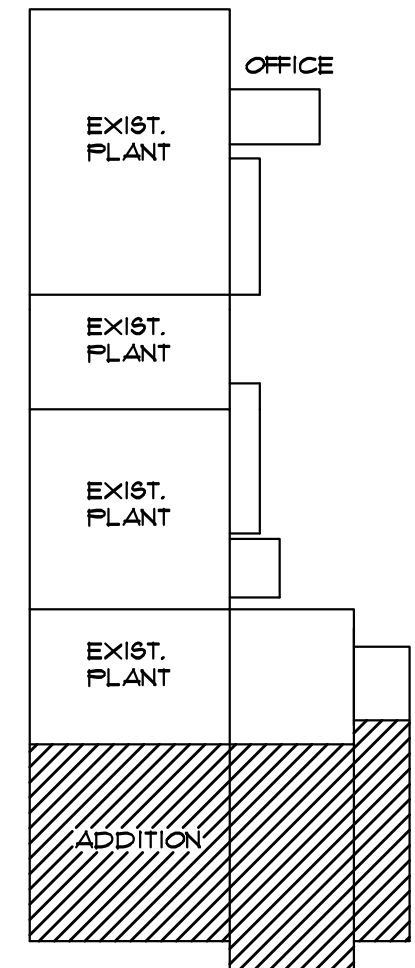

SHEET SIZE: 24x36 - J:\2016\10\07\DELIVERABLES\DRAWINGS\ACAD\CAMACOS\NEW\2016\10\07\POWER PLAN.rvt
SAVED: J:\2016\10\07\DELIVERABLES\DRAWINGS\ACAD\CAMACOS\NEW\2016\10\07\ PLOT: 2016-08-26 17:07

MARK LESNER
ARCHITECT, INC.
ARCHITECTS

45180 Middle Ridge Road
Amherst, Ohio 44001
Phone: 440.988.8122
Fax: 440.988.9109
MARKLESNER@CENTURYLINK.NET

CAMACO
LORAIN MANUFACTURING
3400 RIVER INDUSTRIAL PARK ROAD
LORAIN, OH 44022

Scale: 1/16" = 1'-0"	Date: 082616	Job Number: 1603
Revisions:		Sheet: E3 of E8